



FIRST FLOOR PLAN 1/4"=1'-0"

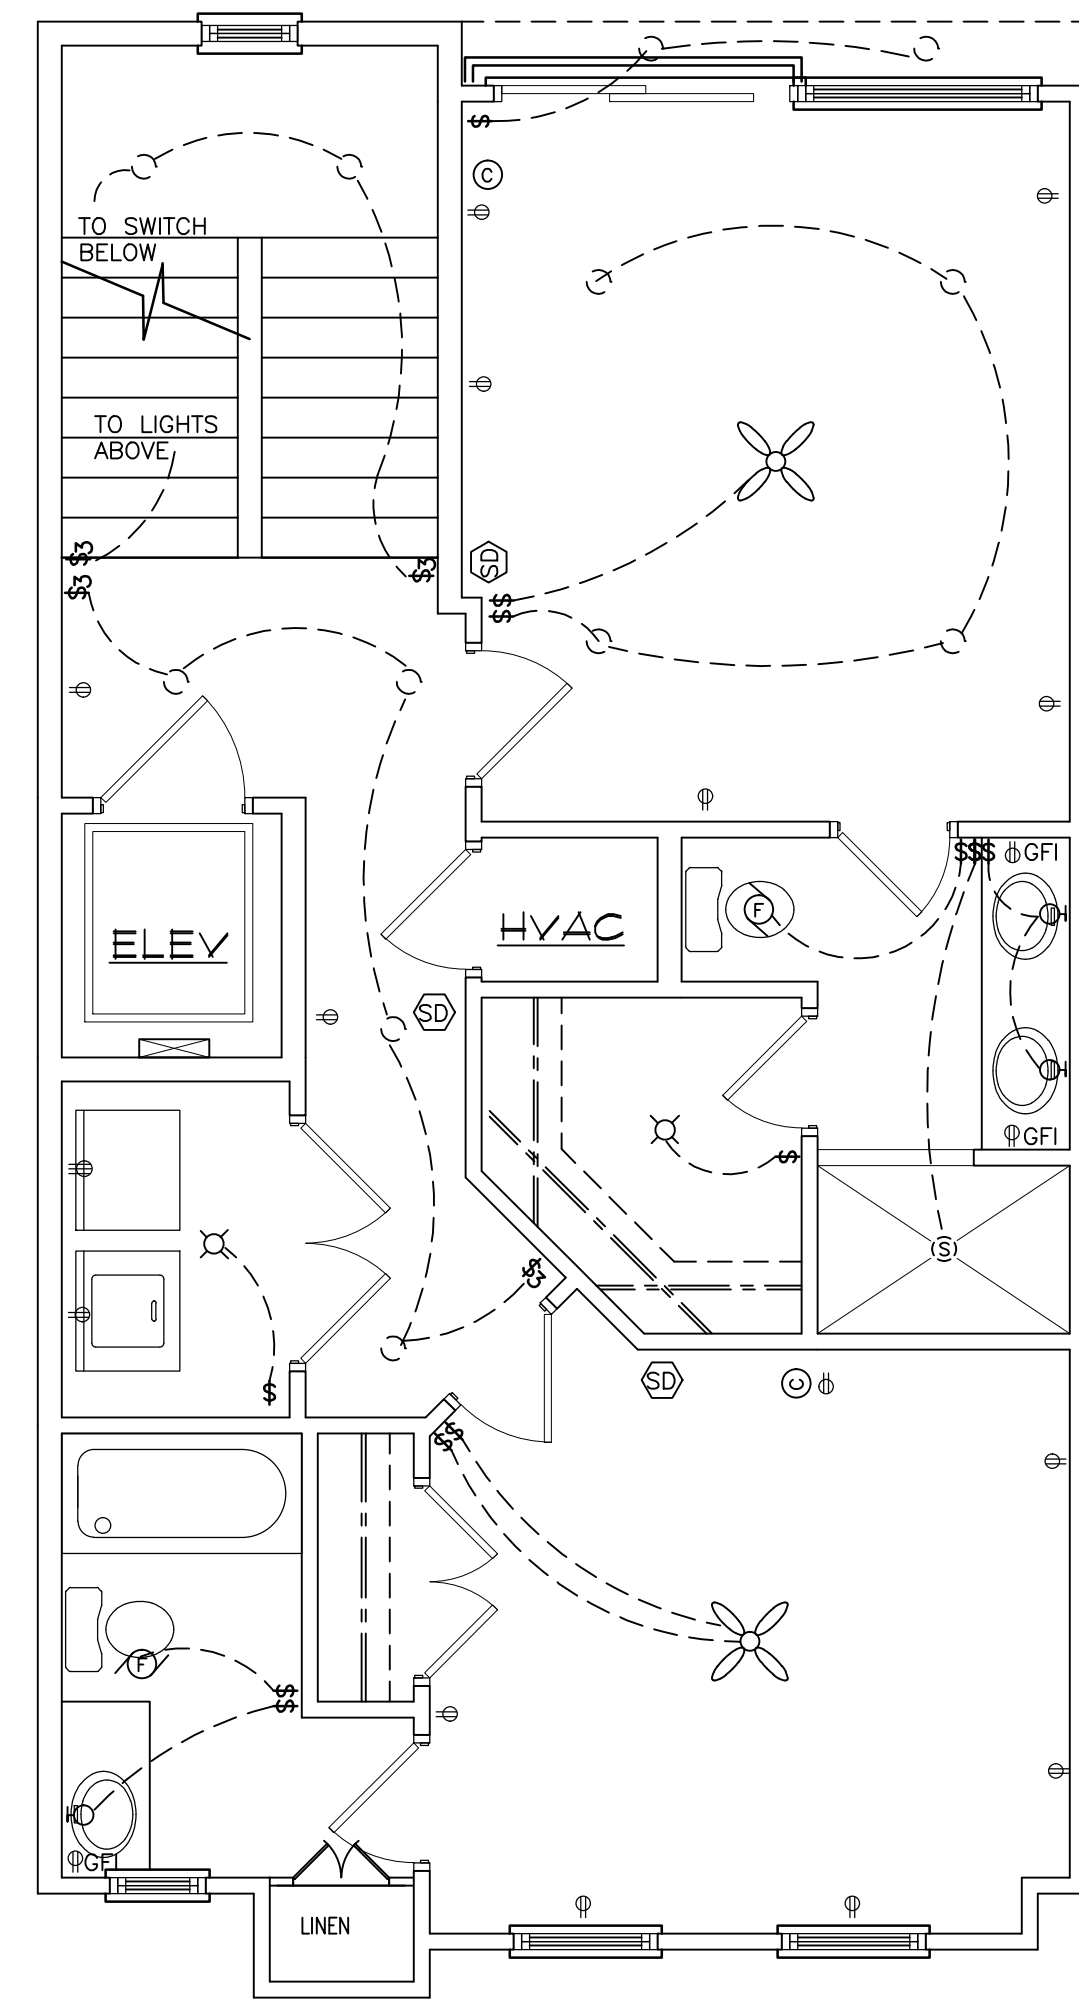

SECOND FLOOR PLAN 1/4"=1'-0"

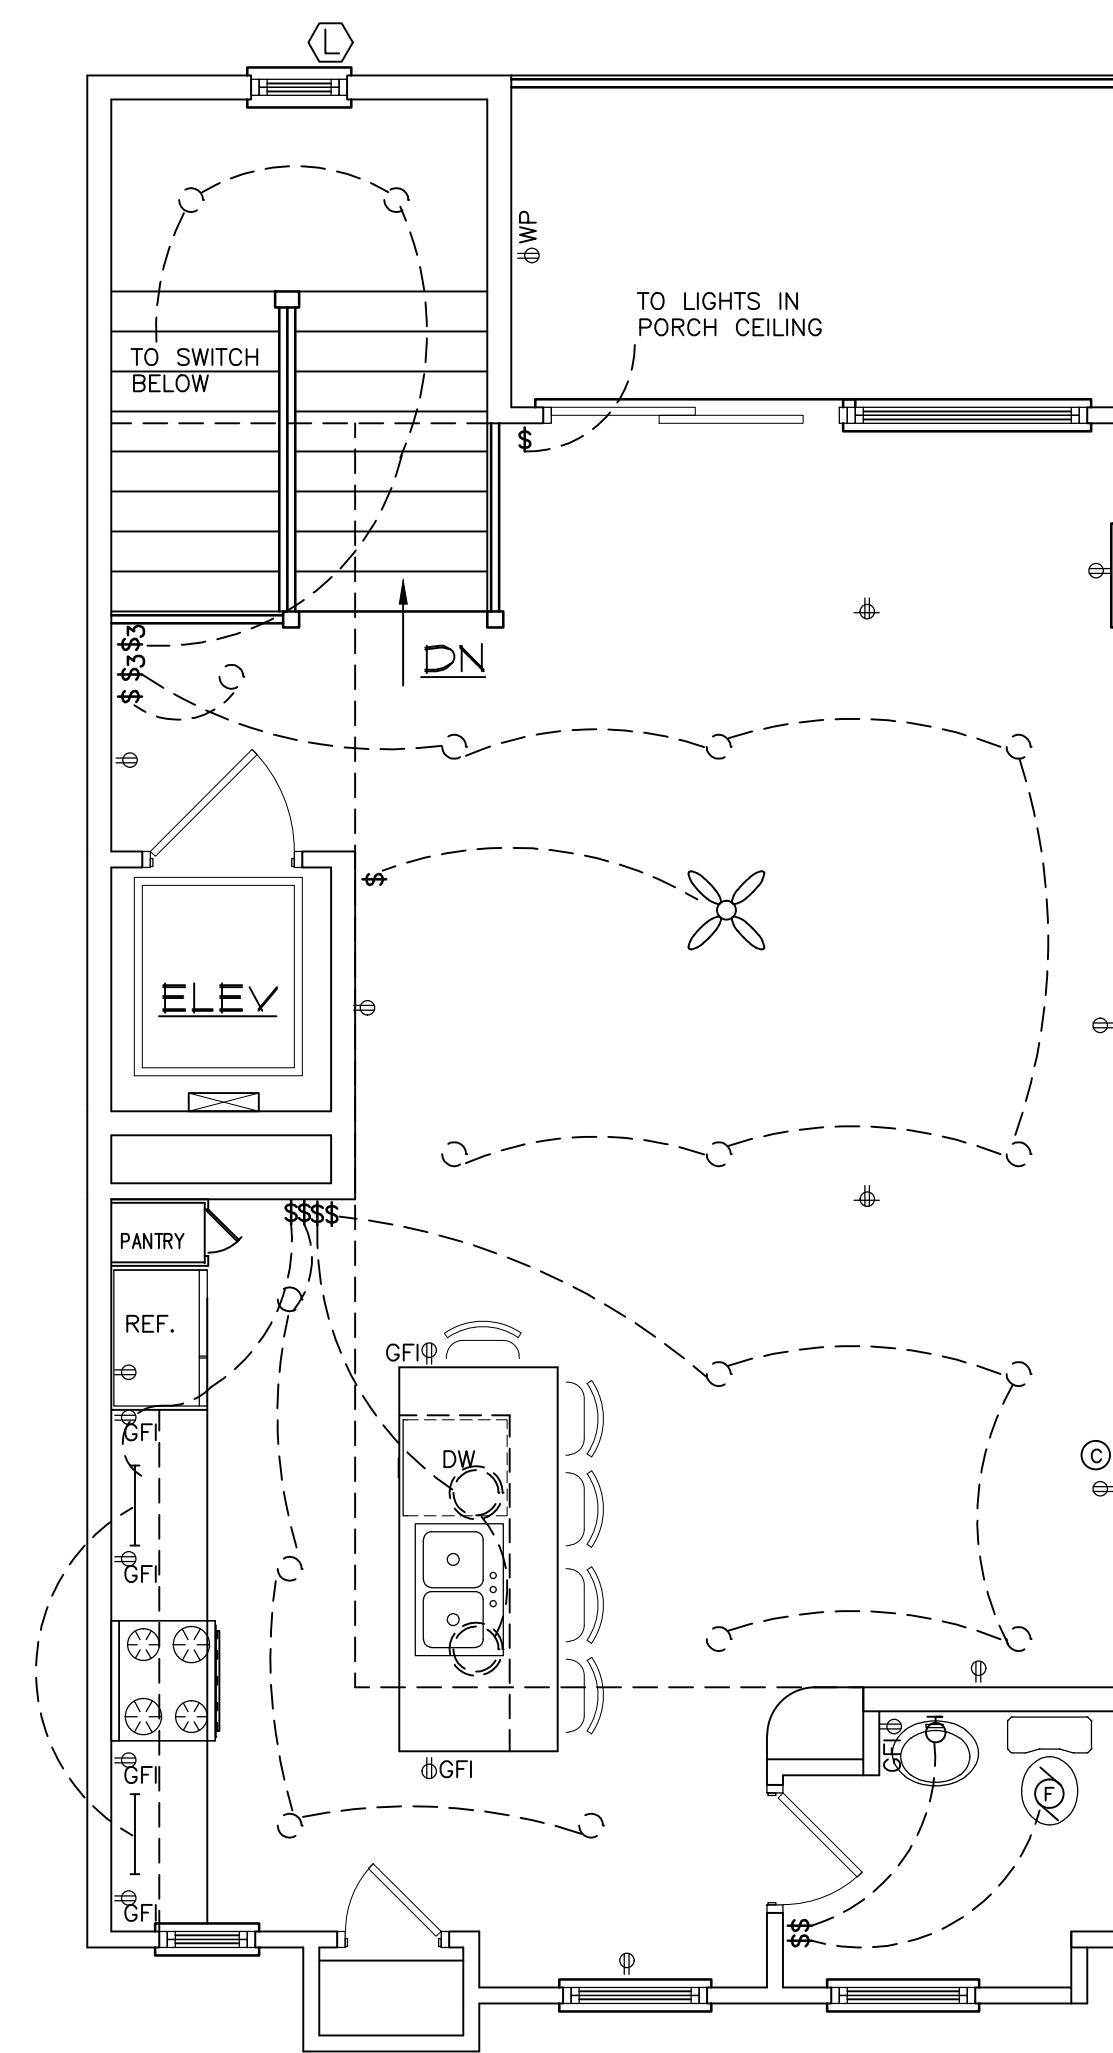

THIRD FLOOR PLAN 1/4"=1'-0"

ELECTRICAL LEGEND			
⊕	SURFACE MOUNTED "EYEBALL" LIGHT	⊕	IN-WALL FLUSH MOUNTED SPEAKER
⊙	WALL MOUNTED INCANDESCENT	⊕	JUNCTION BOX
⊗	SURFACE MTD. INCANDESCENT	—	ELECTRICAL PANEL BOX
⊖	RECESSED "HI-HAT" LIGHTS	⚡	SINGLE POLE TOGGLE (42" AFF)
⊗	DOOR SWITCHED INCANDESCENT D.S.	⚡	THREE WAY TOGGLE SWITCH (42" AFF)
⊗	2" HALOGEN	⚡	FOUR WAY TOGGLE SWITCH (42" AFF)
—	2'-0" FLUORESCENT (SINGLE)	⚡	SINGLE POLE TOGGLE DIMMER (42" AFF)
⊕	2'X4' SURFACE MTD. FLUOR.	⊕	110 V. DUPLEX OUTLET 12" AFF
⊕	EXT. WALL MTD. FLOOD LIGHTS	⊕	110 V. DUPLEX OUTLET 12" AFF (SWITCHED-1/2 HOT)
⊕	SURFACE MTD. CLG. FAN (W/ LIGHT AS PER OWNER)	⊕	110 V. DUPLEX OUTLET (? AFF)
⊕	CABLE TELEVISION	⊕	110 V. DUPLEX OUTLET FLUSH MTD.
⊕	TELEPHONE OUTLET 12" AFF	⊕	110 V. DUPLEX OUTLET (WEATHER-PROOF)
⊕	EXHAUST FAN W/OR W/OUT LIGHT	⊕	220 V. OUTLET Ⓢ DRYER
⊕	SEALED RECESSED FIXTURE INCANDESCENT CONNECTED TO A "GFI" CIRCUIT	⊕	COMBINATION SMOKE/CO DETECTOR TO RECEIVE PRIMARY POWER FROM BUILDING WITH BATTERY BACKUP.

PROVIDE ARC FAULT CIRCUIT INTERRUPTERS (AFCI) AS REQUIRED BY THE NATIONAL ELECTRIC CODE

NOTE:
DAVIS ARCHITECTURE IS NOT LICENSED TO PROVIDE ENGINEERING SERVICES. THESE ELECTRICAL LAYOUTS ARE ONLY AN INDICATION OF THE SCOPE OF THE WORK TO BE PERFORMED. THESE SCOPE DRAWINGS ARE TO BE REVIEWED BY A LICENSED ENGINEER OR LICENSED CONTRACTOR AND AMENDED AS NEEDED PRIOR TO CONSTRUCTION.

JOB NAME	
JOB NUMBER	202264
DATE	4.10.15
DRAWING CODE	E
SHEET NUMBER	A-12

FLOW TOWNHOMES
 © 2015 DAVIS ARCHITECTURE, INC. ALL RIGHTS RESERVED
 ELECTRICAL LAYOUTS - UNIT B

DAVIS
ARCHITECTURE

24 OFFICE PARK COURT
COLUMBIA, SC 29223
803.699.0844
803.403.8981 FAX
MDAVIS@DAVISARCHITECTURE.COM